


**STATE OF CALIFORNIA  
COUNTY OF TRINITY**

**DEPARTMENT OF TRANSPORTATION**

**PROJECT PLANS FOR CONSTRUCTION ON  
LANCE GULCH ROAD**

**IN TRINITY COUNTY  
IN WEAVERVILLE  
ALONG AND BETWEEN STATE ROUTE 3  
AND STATE ROUTE 299**

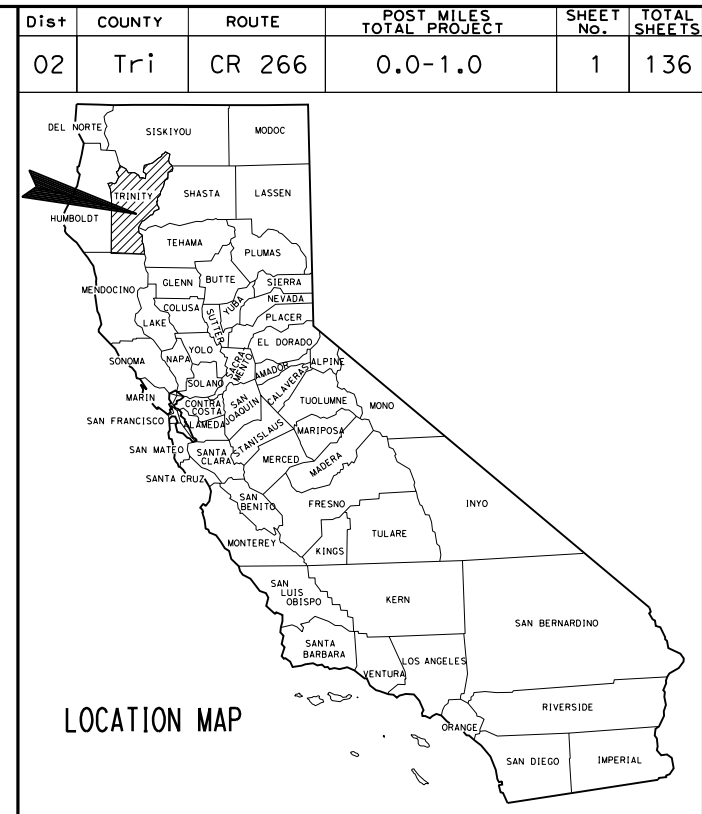

**INDEX OF PLANS**


SHEET No.	DESCRIPTION
1	TITLE SHEET
2-3	TYPICAL CROSS SECTIONS
4	KEY MAP AND INDEX
5-10	LAYOUT
11-18	PROFILE AND SUPERELEVATION DIAGRAM
19-26	CONSTRUCTION DETAILS
27-32	EROSION CONTROL PLAN
33-35	CONTOUR GRADING
36-41	DRAINAGE PLAN
42-47	DRAINAGE PROFILE
48-58	DRAINAGE DETAILS
59-62	DRAINAGE QUANTITIES
63-68	UTILITY PLAN
69	CONSTRUCTION AREA SIGNS
70-74	STAGE CONSTRUCTION AND TRAFFIC HANDLING PLAN
75-81	PAVEMENT DELINEATION AND SIGN PLAN
82-85	PAVEMENT DELINEATION QUANTITIES
86-91	SUMMARY OF QUANTITIES
92-118	WETLAND AND RIPARIAN MITIGATION
119-121	ELECTRICAL PLANS

TO BE SUPPLEMENTED BY STATE OF CALIFORNIA STANDARD PLANS DATED 2010

**STRUCTURE PLANS BRIDGE No. 5C-0242**

1	GENERAL PLAN
2	DECK CONTOURS
3	FOUNDATION PLAN
4	ABUTMENT 1 LAYOUT
5	ABUTMENT 4 LAYOUT
6	ABUTMENT DETAILS
7	PIER DETAILS
8	TYPICAL SECTION
9	SUPERSTRUCTURE DETAILS NO. 1
10	SUPERSTRUCTURE DETAILS NO. 2
11	STRUCTURE APPROACH TYPE EQ(10)
12	STRUCTURE APPROACH DRAINAGE DETAILS
13	TUBULAR HAND RAILING (BICYCLE)
14	ARCHITECTURAL DETAILS
15	LOG OF TEST BORINGS

THE STANDARD PLANS LIST APPLICABLE TO THIS CONTRACT IS INCLUDED IN THE NOTICE TO BIDDERS AND SPECIAL PROVISIONS BOOK.

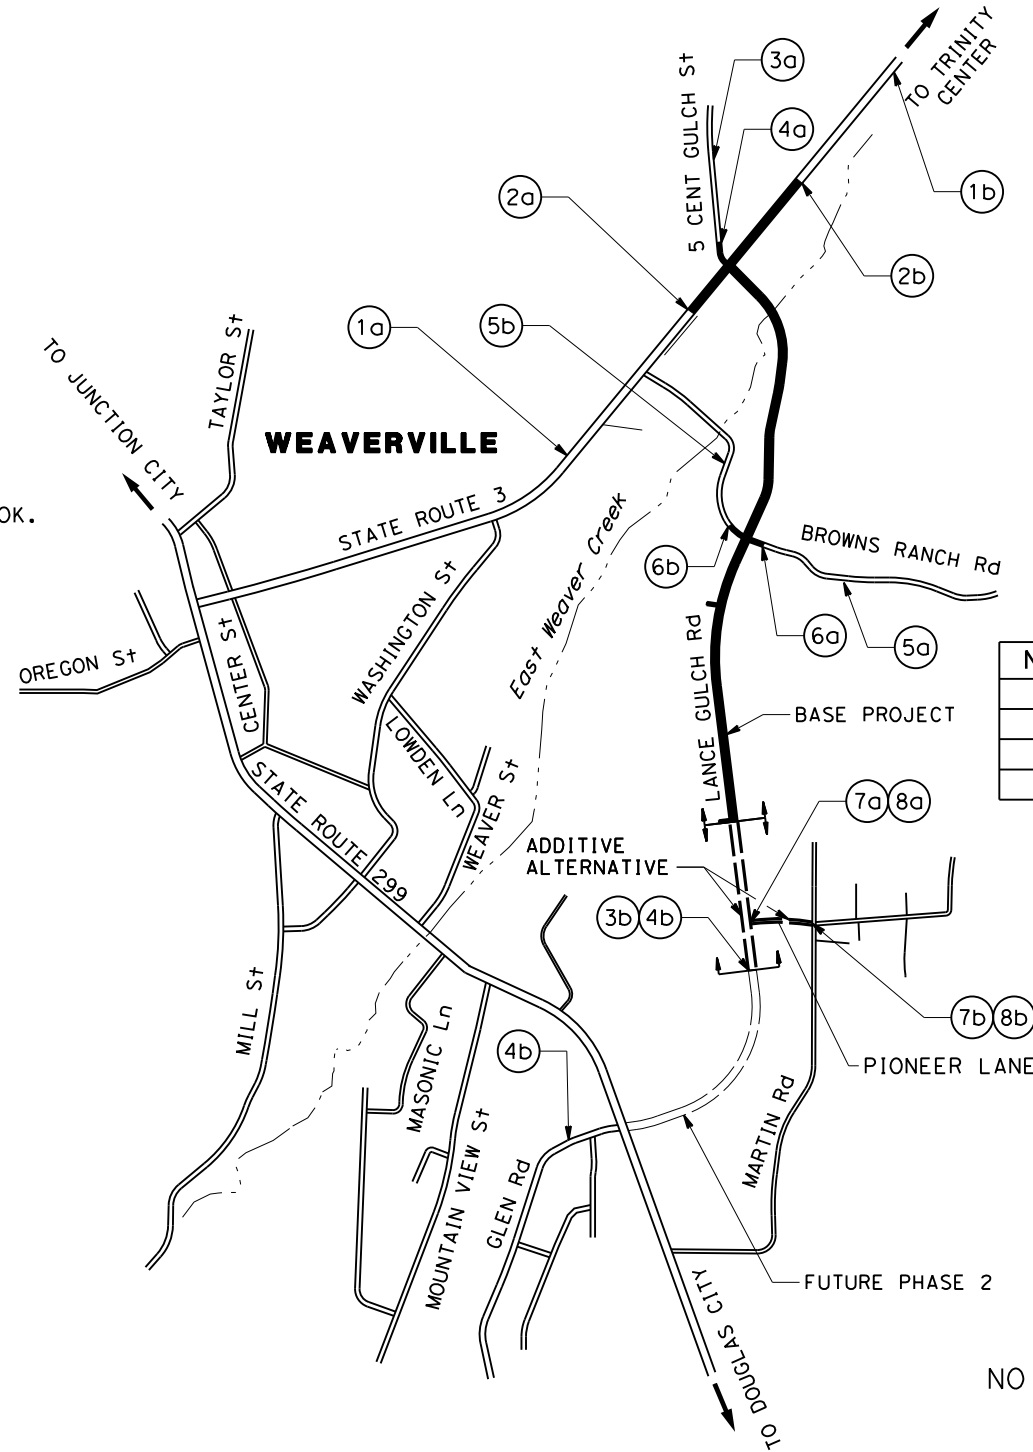

**WORK LIMITS**

No. ○	Begin Work	No. ○	End Work
1a	Sta "HWY 3" 285+79.15	1b	Sta "HWY 3" 326+84.79
3a	Sta "5CG" 199+00.00	3b	Sta "EC" 52+12.91
5a	Sta "BR" 398+30.00	5b	Sta "BR" 406+80.00
7a	Sta "P" 600+00.00	7b	Sta "P" 604+68.72

**CONSTRUCTION LIMITS**

No. ○	BEGIN CONSTRUCTION	No. ○	END CONSTRUCTION
2a	Sta "HWY 3" 300+79.15 PM X.X	2b	Sta "HWY 3" 311+84.79 PM X.X
4a	Sta "5CG" 202+00.00 PM X.X	4b	Sta "EC" 52+12.91 PM X.X
6a	Sta "BR" 401+30.00 PM X.X	6b	Sta "BR" 403+80.00 PM X.X
8a	Sta "P" 600+00.00 PM X.X	8b	Sta "P" 604+68.72 PM X.X



RICHARD C. TIPPETT, DIRECTOR  
TRINITY COUNTY DEPARTMENT OF TRANSPORTATION

THE CONTRACTOR SHALL POSSESS THE CLASS (OR CLASSES) OF LICENSE AS SPECIFIED IN THE "NOTICE TO BIDDERS."

*James L. Foster Jr.* 11/22/13  
PROJECT MANAGER DATE  
REGISTERED CIVIL ENGINEER

PLANS APPROVAL DATE  
THE STATE OF CALIFORNIA OR ITS OFFICERS OR AGENTS SHALL NOT BE RESPONSIBLE FOR THE ACCURACY OR COMPLETENESS OF SCANNED COPIES OF THIS PLAN SHEET.



QUINCY ENGINEERING  
3247 RAMOS CIRCLE  
SACRAMENTO, CA 95827-2501

CONTRACT No. **00-000004**  
PROJECT ID **000000000**